

STATE	PROJECT NO.	COUNTY	SHEET NO.
NEVADA	NHP-080-1(178)	CHURCHILL	1

INDEX OF SHEETS

1 - 1A	TITLE SHEETS AND LOCATION SKETCHES
2 - 2F	TYPICAL CROSS SECTIONS
3 - 3F	GENERAL NOTES AND SUMMARIES
4 - 26	ROADWAY PLAN AND PROFILE
LC1 - LC13	LOCATION CONTROL
SD1	SPECIAL DETAIL
D1 - D29	DRAINAGE PLANS
DD1 - DD4	DRAINAGE DETAILS
DS1 - DS6	DRAINAGE STRUCTURE LIST
ST1	PERMANENT STRIPING DETAILS
LT1 - LT12	LIGHTING PLANS
TS1 - TS23	PERMANENT SIGNING
B1 - B8	BRIDGE SHEETS
S1 - S3	STRUCTURE LIST

STATE OF NEVADA
 DEPARTMENT OF TRANSPORTATION
CONSTRUCTION PLANS

LARGE TEXT, FT=3 PROJECT LOCATION


4. → I 80 FROM LYON/CHURCHILL COUNTY LINE TO 8.755 MILES EAST OF NIGHTINGALE INTERCHANGE
 3. → CHURCHILL COUNTY
 CH 0.00 to CH 12.823

DESIGN CRITERIA

- XXXX NDOT "STANDARD PLANS FOR ROAD AND BRIDGE CONSTRUCTION"
- XXXX AASHTO "A POLICY ON GEOMETRIC DESIGN OF HIGHWAYS AND STREETS"
- XXXX FHWA "M.U.T.C.D."
- XXXX AASHTO "ROADSIDE DESIGN GUIDE"
- XXXX NDOT "ROAD DESIGN MANUAL"
- AADT = XXX (if Applicable)


1. → **PRELIMINARY**
 5/4/2022 - 90% SUBMITTAL
 SUBJECT TO REVISION

ROUTE LOCATION

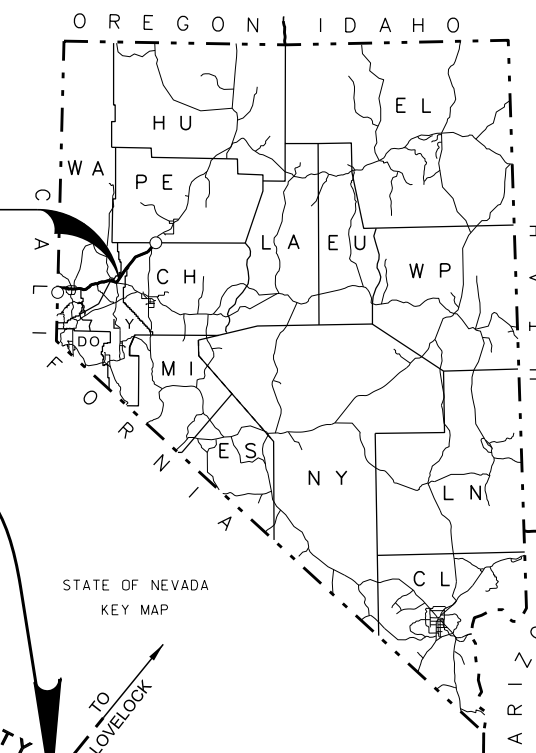

BEGIN ROUTE IR80 SECTION-1
 CA/NV STATE LINE

END ROUTE IR80 SECTION-1
 CH/PE COUNTY LINE

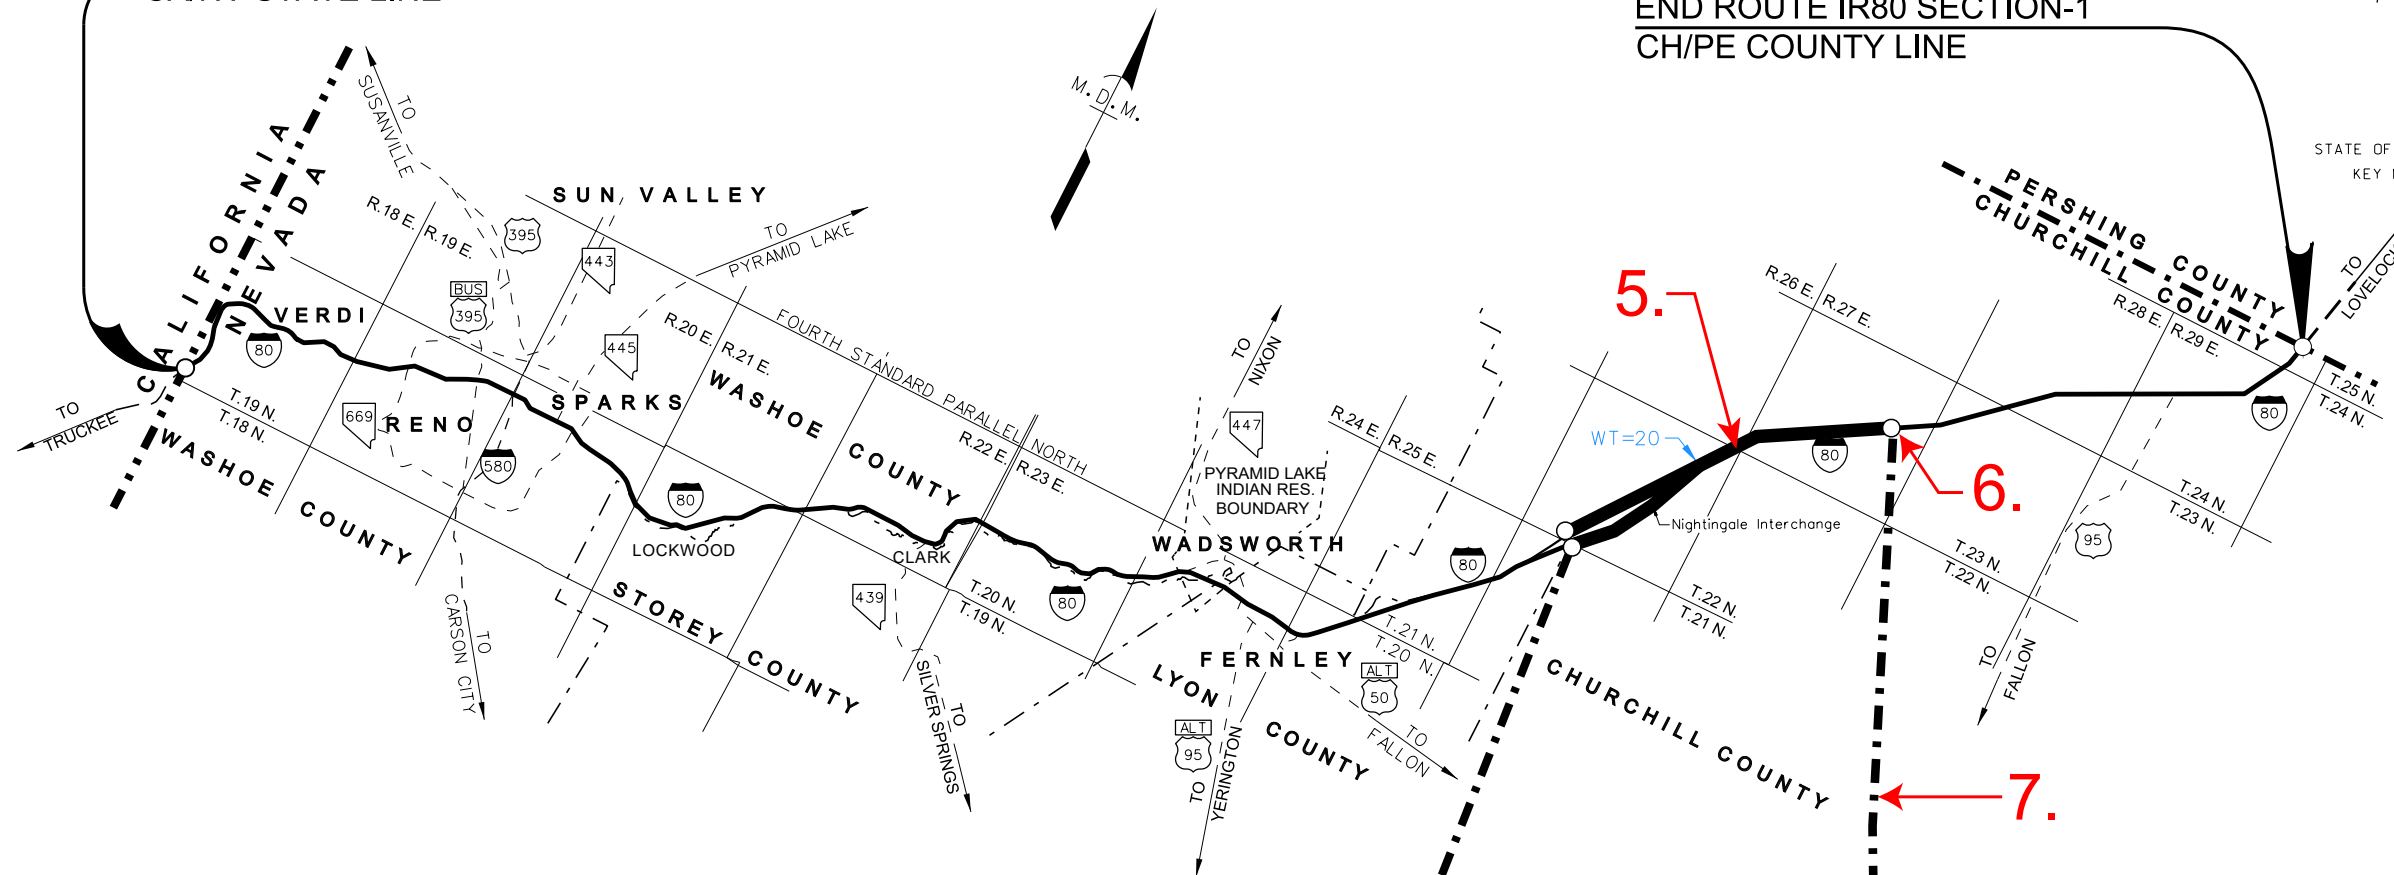

EASTBOUND ALIGNMENT BAR

BEGIN CONSTRUCTION "XE" 584+76.48 P.O.T.	BEGIN PROJECT NHP-080-1(178) "XE" 586+51.48 P.O.T.	"XE" 706+37.15 P.I. = "LE" 100+00.00 P.O.T.	"LE" 194+77.88 P.O.T. STRUCTURE I-845 E "LE" 195+10.88 P.O.T.	"LE" 337+08.61 P.I. = "LE" 337+55.86 P.O.T. =	END PROJECT NHP-080-1(178) "LE" 658+17.11 P.O.T.	END CONSTRUCTION "LE" 659+92.11 P.O.T.
---	---	--	---	--	---	---

WESTBOUND ALIGNMENT BAR

BEGIN CONSTRUCTION "XW" 584+76.48 P.O.T.	BEGIN PROJECT NHP-080-1(178) "XW" 586+51.48 P.O.T.	"XW" 701+85.13 P.I. = "LW" 100+00.00 P.O.T.	"LW" 198+45.16 P.O.T. STRUCTURE I-845 W "LW" 198+78.16 P.O.T.	"LW" 218+05.04 P.I. = "LW" 214+41.13 P.O.T. =	END PROJECT NHP-080-1(178) "LW" 658+17.11 P.O.T.	END CONSTRUCTION "LW" 659+92.11 P.O.T.
---	---	--	---	--	---	---

CONTRACT 3299 BACK
 BEGIN PROJECT NHP-080-1(178)
 "XE" 586+51.48 P.O.T.
 "XW" 586+51.48 P.O.T.

PROJECT NHP-080-1(178)	
1-INCH COLDMILL WITH 2-INCH PLANTMIX BITUMINOUS SURFACE WITH OPEN GRADED SURFACE, 2% PATCH	
LENGTH OF CONSTRUCTION ON EASTBOUND LANES	12.841 MILES
LENGTH OF CONSTRUCTION ON WESTBOUND LANES	12.756 MILES
LENGTH OF ROUTE SECTION	88.712 MILES
TO BE CONTRACTED	



8. →

CONTRACT ### AHEAD
 END PROJECT NHP-080-1(178)
 "LE" 658+17.11 P.O.T.
 "LW" 658+17.11 P.O.T.

APPROVED SEPTEMBER 5, 2012

_____, DIRECTOR, DEPT. OF
 TRACY LARKIN-THOMASON, P.E. TRANSPORTATION

GOVERNOR JOE LOMBARDO
 CHAIRMAN, TRANSPORTATION BOARD



DESIGN DIVISION		
DESIGNER	DESIGNER NAME	PHONE (###) ###-####
SENIOR DESIGNER	SENIOR DESIGNER NAME	PHONE (###) ###-####
PROJECT MANAGER	PROJECT MANAGER NAME	PHONE (###) ###-####